




All dimensions to be checked on site.
Do not scale from this drawing.
Any discrepancies to be reported to the project surveyor.

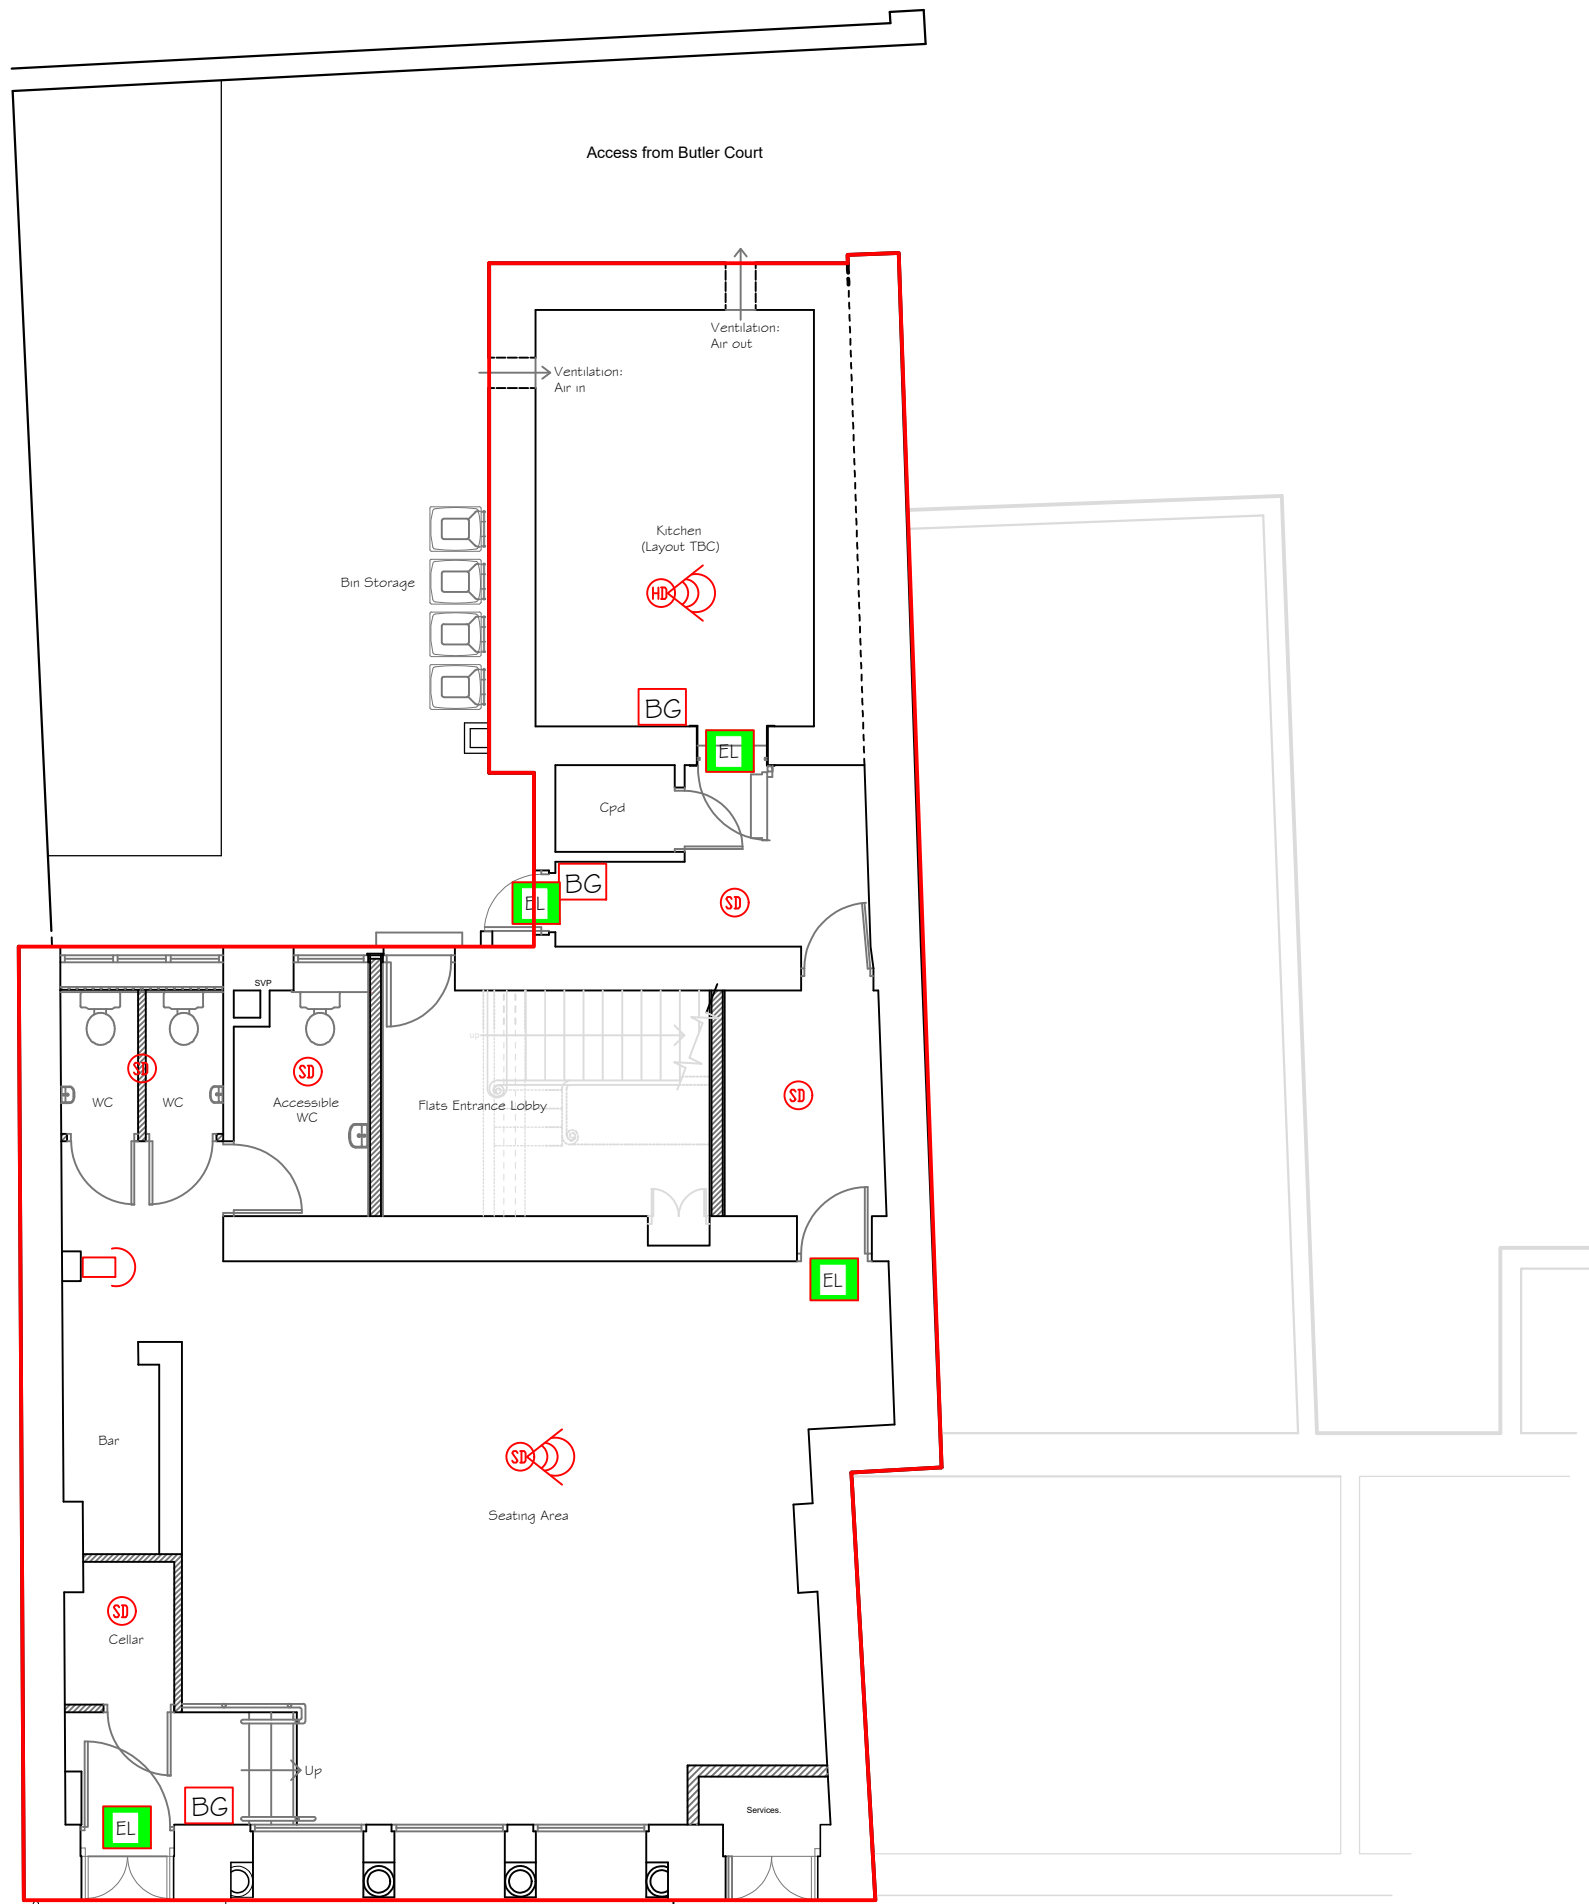

GROUND FLOOR PLAN

- Heat Detector
- Smoke Detector
- Smoke Detector with Sounder Base
- Heat Detector with Sounder Base
- Sounder
- Break Glass
- Emergency Fire Escape with direction arrow, bulk head lighting

Title: Licensing Drawing	
Project & Client: Darcys 21 High Street Wooler NE71 6BU	
No. LD-01	REVISIONS
Scale: 1:100 @ A3	Date: November 2022
	Drawn by: CW

CHRIS WAITE
BUILDING SURVEYING SERVICES

Phone - 07595 780 895
Email - chris@chriswaitesurveying.co.uk
www.chriswaitesurveying.co.uk