
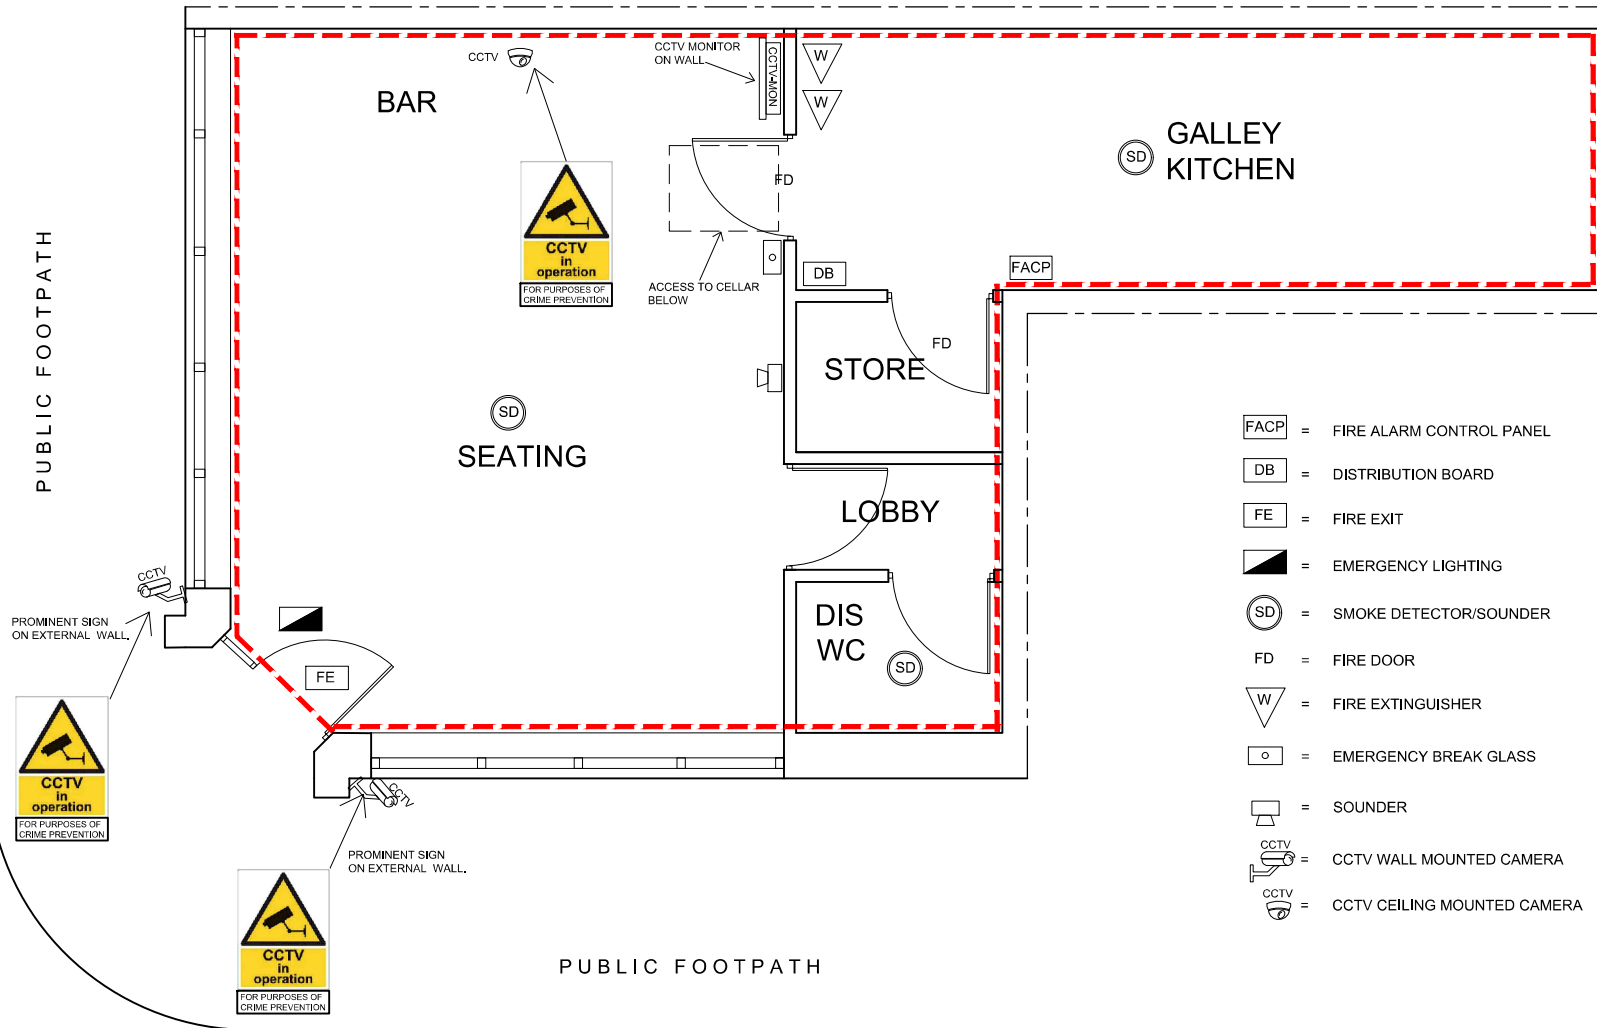



----- = AREA TO BE COVERED BY LICENCE

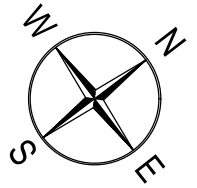



- FACP = FIRE ALARM CONTROL PANEL
- DB = DISTRIBUTION BOARD
- FE = FIRE EXIT
- ▬ = EMERGENCY LIGHTING
- SD = SMOKE DETECTOR/SOUNDER
- FD = FIRE DOOR
- W = FIRE EXTINGUISHER
- = EMERGENCY BREAK GLASS
- ☐ = SOUNDER
- CCTV (wall icon) = CCTV WALL MOUNTED CAMERA
- CCTV (ceiling icon) = CCTV CEILING MOUNTED CAMERA

A	INITIAL ISSUE	11.04.25	SH	
REV	DESCRIPTION	DATE	BY	
STATUS LICENSING APPLICATION				
APPLICANT				
MR. P. GALLAGHER 6, PLESSEY ROAD BLYTH NE24 3AD				
TITLE				
EXISTING RESTAURANT PROPOSED LAYOUT GROUND FLOOR PLAN				
McGREGOR ASSOCIATES LTD CONSULTING CIVIL AND STRUCTURAL ENGINEERS & BUILDING DESIGN CONSULTANTS				
 12c, ALBION HOUSE WEST PERCY STREET NORTH SHIELDS TYNE & WEAR NE29 0DW				
TEL: 0191 2592300 E-MAIL: info@mcgregorassociates.co.uk				
DATE	SCALE	DRAWN	CHECKED	APPRV.
APRIL 2025	1:50	SH		
JOB NUMBER	DRAWING NUMBER	REV	SIZE	
5/4580	01	A	A3	

 
SCALE IN METRES



----- = AREA TO BE COVERED BY LICENCE

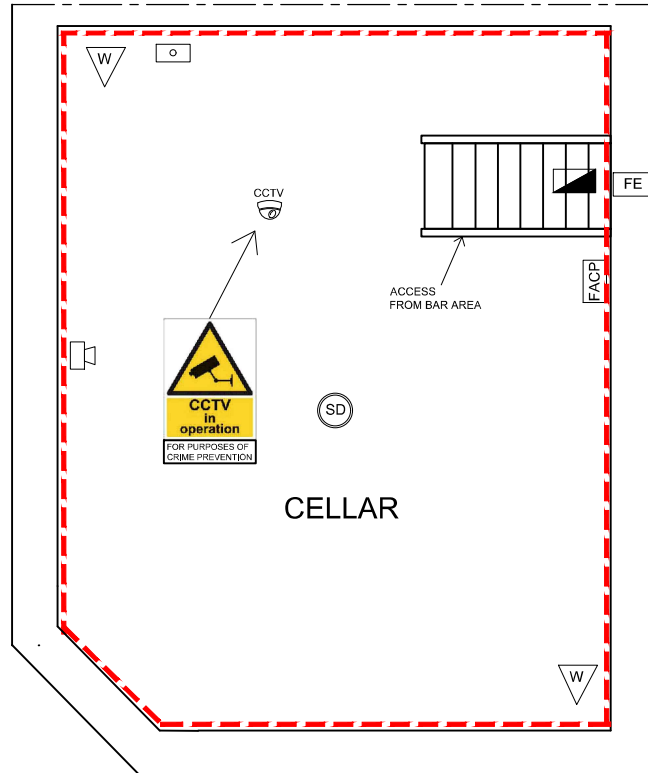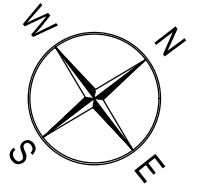

- FACP = FIRE ALARM CONTROL PANEL
- DB = DISTRIBUTION BOARD
- FE = FIRE EXIT
- Emergency Lighting
- SD = SMOKE DETECTOR/SOUNDER
- FD = FIRE DOOR
- W = FIRE EXTINGUISHER
- Emergency Break Glass
- Sounder
- CCTV = CCTV WALL MOUNTED CAMERA
- CCTV = CCTV CEILING MOUNTED CAMERA

A	INITIAL ISSUE	11.04.25	SH
REV	DESCRIPTION	DATE	BY
STATUS LICENSING APPLICATION			
APPLICANT			
MR. P. GALLAGHER 6, PLESSEY ROAD BLYTH NE24 3AD			
TITLE			
EXISTING RESTAURANT PROPOSED LAYOUT CELLAR/BASEMENT PLAN			
McGREGOR ASSOCIATES LTD CONSULTING CIVIL AND STRUCTURAL ENGINEERS & BUILDING DESIGN CONSULTANTS			
 12c, ALBION HOUSE WEST PERCY STREET NORTH SHIELDS TYNE & WEAR NE29 0DW			
TEL: 0191 2592300 E-MAIL: info@mcgregorassociates.co.uk			
DATE	SCALE	DRAWN	CHECKED
APRIL 2025	1:50	SH	
JOB NUMBER	DRAWING NUMBER	REV	SIZE
5/4560	02	A	A3